

TraumaCon

March 30 - 31, 2022

Planet Hollywood - Celebrity Ballroom 4, 6-8 - Level 1
Las Vegas, NV



Show Information	
Show Name	TraumaCon
Show Dates	March 30 - 31, 2022
Move-In	3/30/2022
Job #	L190860322
AE	Corey Nickel

40 - 72" Banquet Rounds
Seating for 400

Inventory as of 11/17/2021


Dimension	Size	Qty	SqFt
8'x10'	80	50	4,000
Totals:		50	4,000

BUILDING LEGEND	
FE	FIRE EXTINGUISHER
FHC	FIRE HOSE CABINET
FS	FIRE STROBES LOCATED 7' 5" OFF THE GROUND

Venue Info	
Building Name	Planet Hollywood
Hall	Celebrity Ballroom 4, 6-8
Floor	Level 1
Address	3667 S Las Vegas Blvd Las Vegas, NV 89109

Drawing Information	
File Path	Z:\11 Floor Plans_01_SEE SHOW FLOORPLANS\202203_Mar01TraumaCon_L190860322
File Name	TraumaCon_L190860322.dwg
Drawn By	Theresa Cannatella
Last Saved	11/15/2021 2:31 PM
Saved By	Tmckee
Tab	Floorplan
Paper Size	ANSI full bleed A (11.00 x 8.50 Inches)
Scale	NTS

1531 Carroll Drive NW
Atlanta, GA 30318
(v) 404-720-8600
(f) 404-720-8750

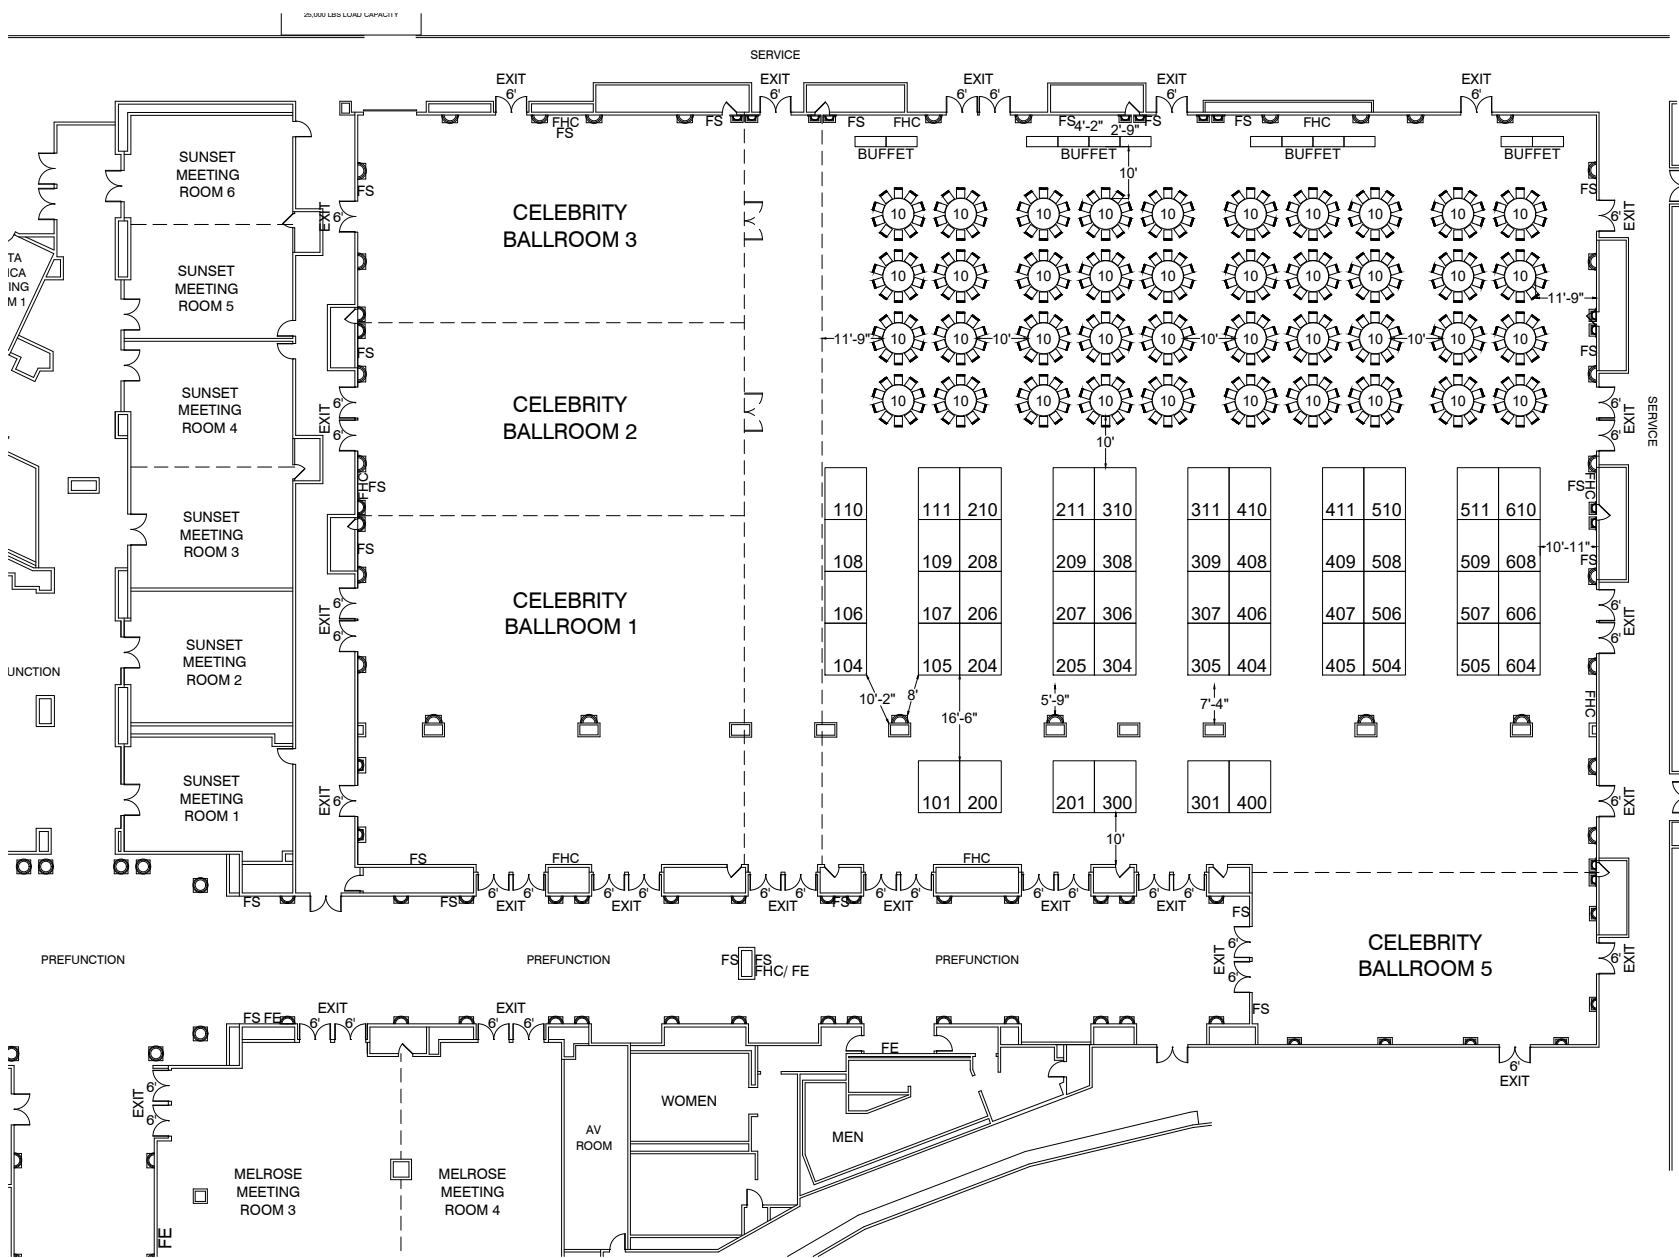

Shepard Exposition Services has made every effort to ensure the accuracy of all information contained on this floor plan. However, no warranties, either expressed or implied, are made with respect to this floor plan. Verifying the locations of building columns, utilities, or other architectural components of the facility is the sole responsibility of the exhibitor/show management.

SUBJECT TO FIRE MARSHAL APPROVAL